



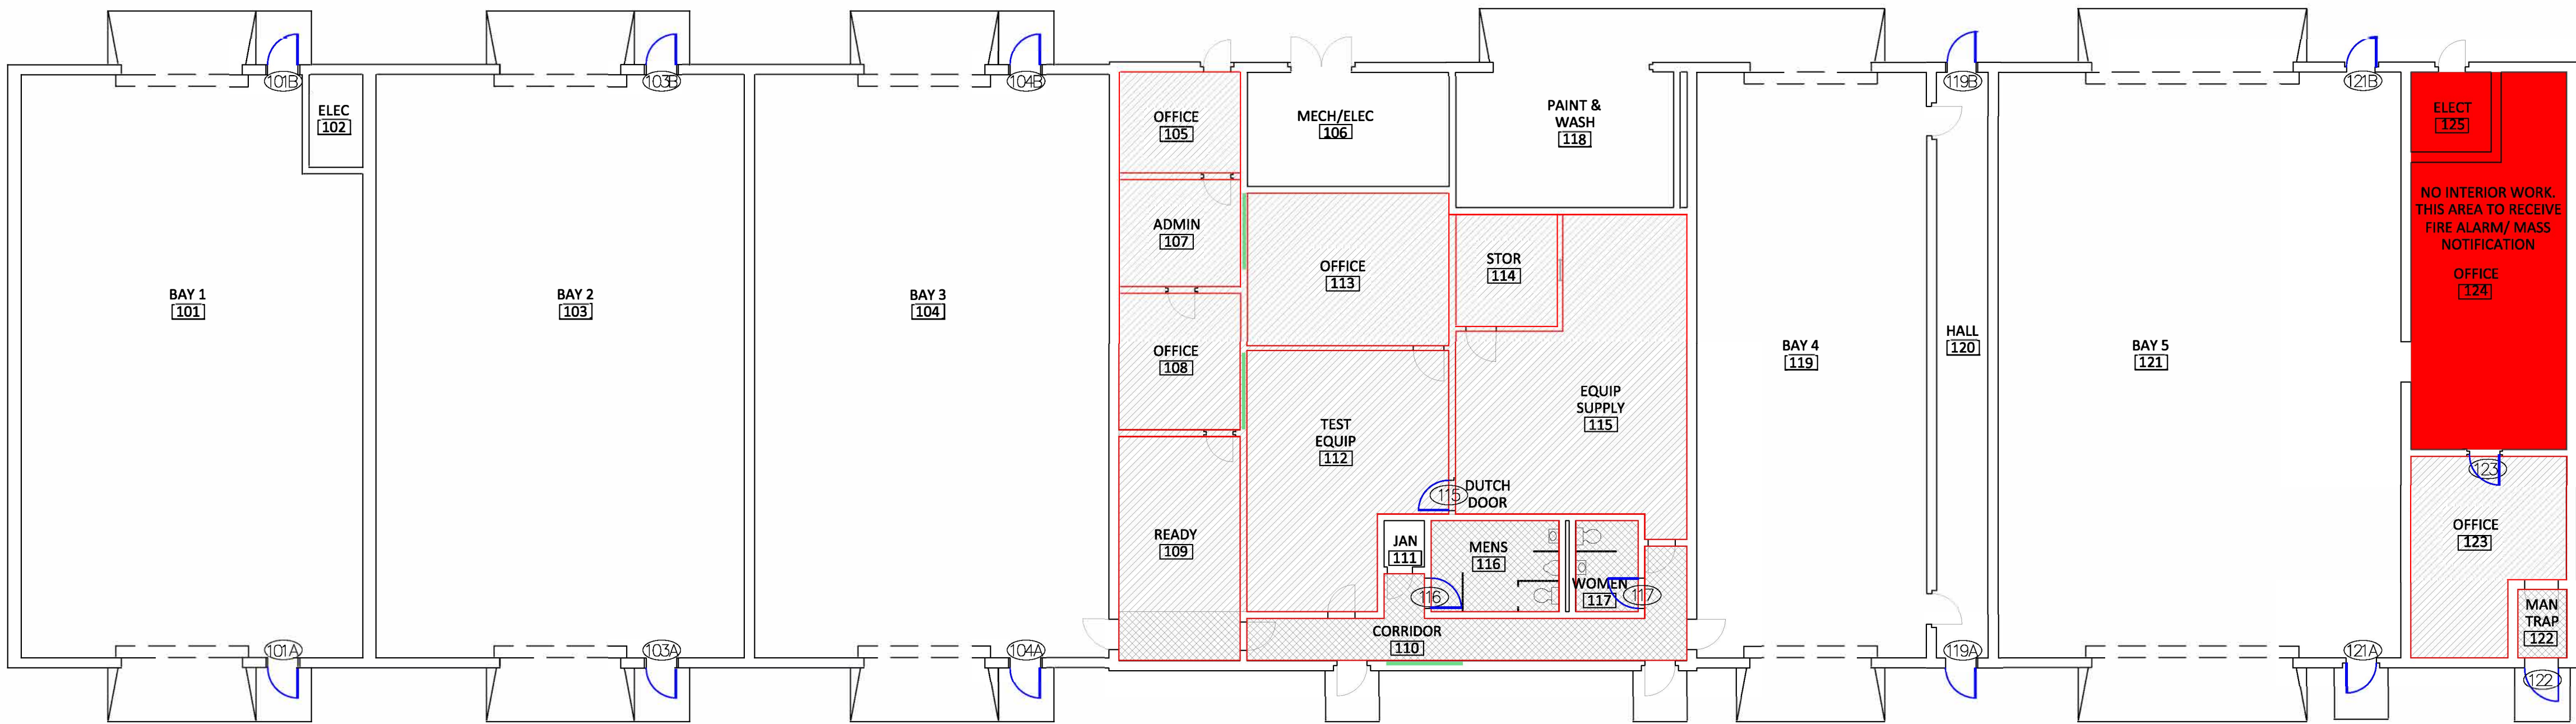

FLOOR PLAN

SCALE: 3/32"=1'-0"

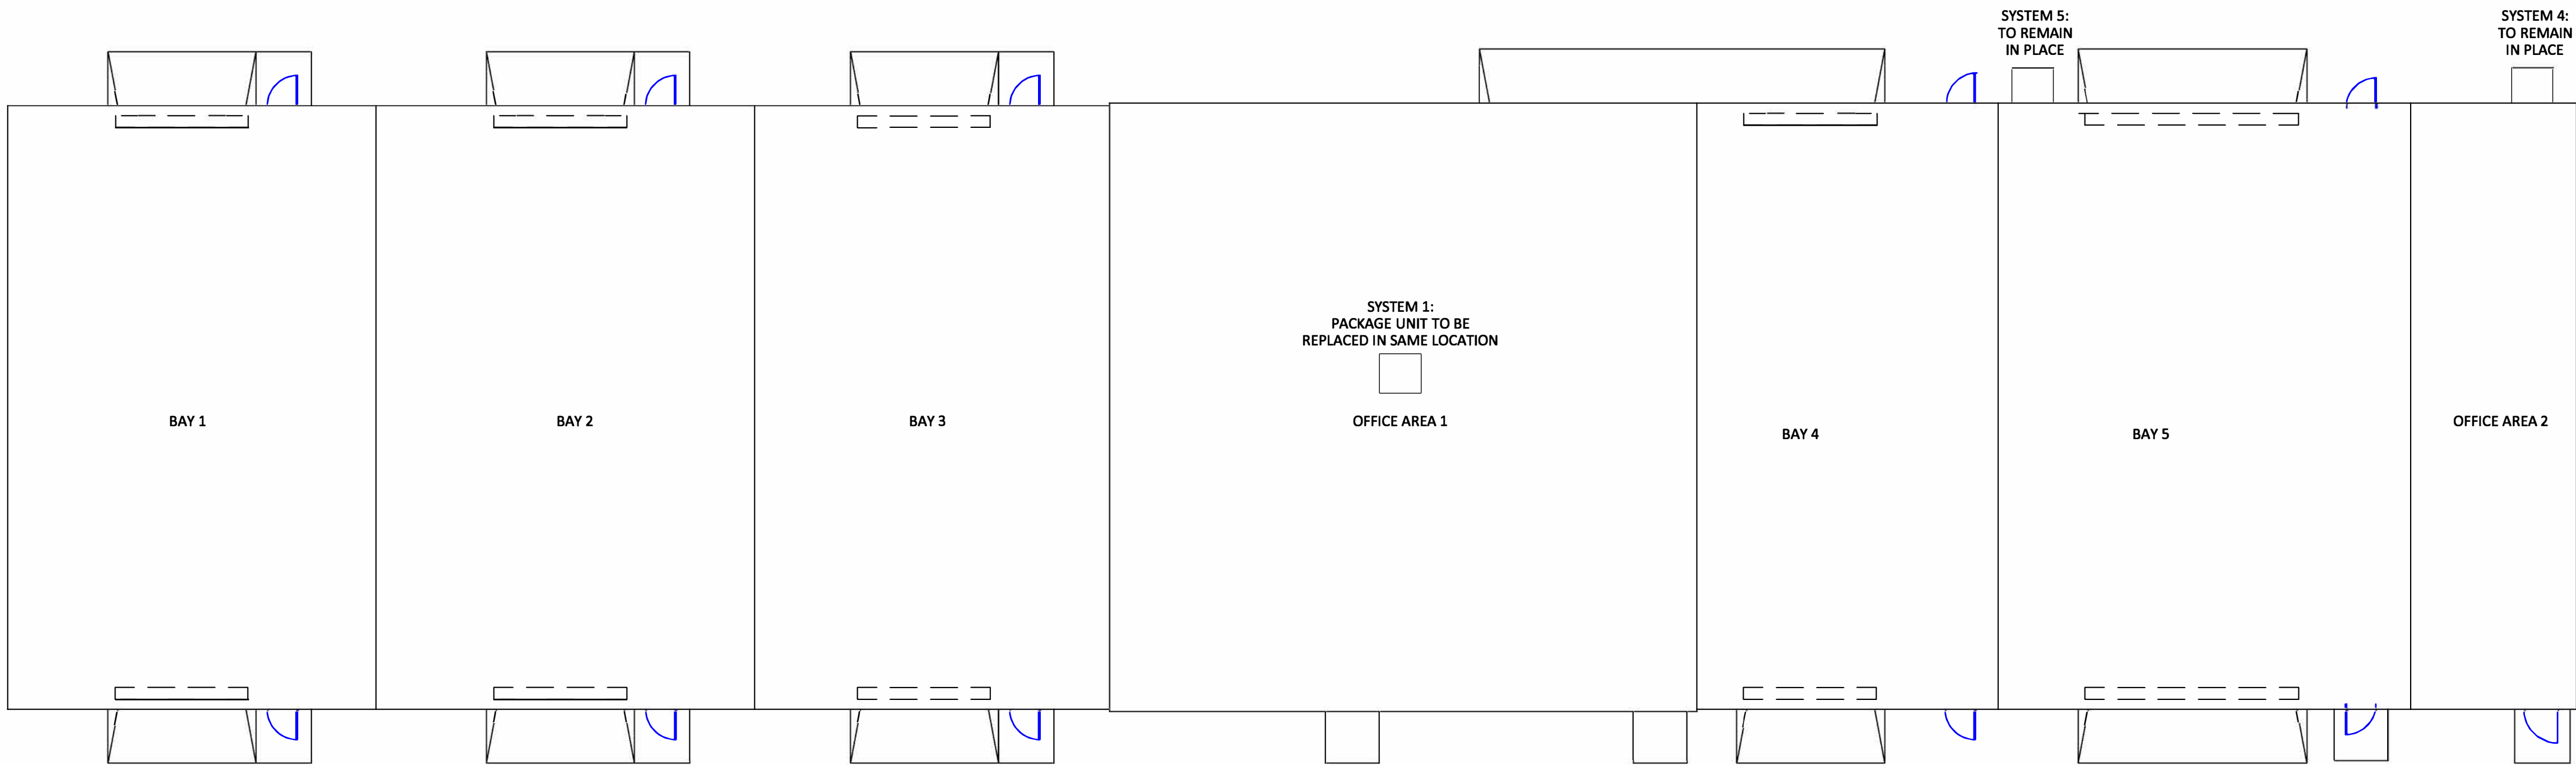

ROOF PLAN

SCALE: 3/32"=1'-0"

- NEW 1/2" GYPSUM WALL BOARD AND FURRING.
- WALLS TO RECEIVE LEVEL 3 FINISH AND PAINTED
- NEW DOORS DENOTED IN BLUE (EXTERIOR DOORS SHALL RECEIVE NEW DOORS AND FRAMES)
- NEW CARPET - MOHAWK, LIVE AND LEARN SIDE STRIPE 859 FRANKLIN
- NEW LVT - MOHAWK, LIVING LOCAL COLOR TBD

20th CIVIL ENGINEER SQUADRON

428 CHAPIN STREET
SHAW AIR FORCE BASE, SOUTH CAROLINA 29152
COMMERCIAL PHONE: 1-803-895-9632 COMMERCIAL FAX: 1-803-895-9626

BLDG 1816

FLOOR PLAN

FLOOR PLAN		DESCRIPTION OF REVISION		DATE	REV BY
ENGINEER	A1C FLETCHER				
PROJECT NUMBER	9DEC04				
DATE	3/32"=1'-0"				
SCALE	1				
SHEET	1				
OF	1				

Proposed: Install new 4x2 reducer, valve and capped stub for future connection to B1817

B1816

Existing Gas 4" line

Elec

Comm

Water

Sewer

Water


Proposed: Install New 4" Gas Service line

Existing Utilities and Proposed Gas Service

Proposed: Install new tee and 4x2 reducer, 2" supply line to B1816.


Proposed: Install new 4x2 reducer, valve and capped stub for future connection to B1815


New utilities have recently been installed along this dirt road which are not shown on this plan

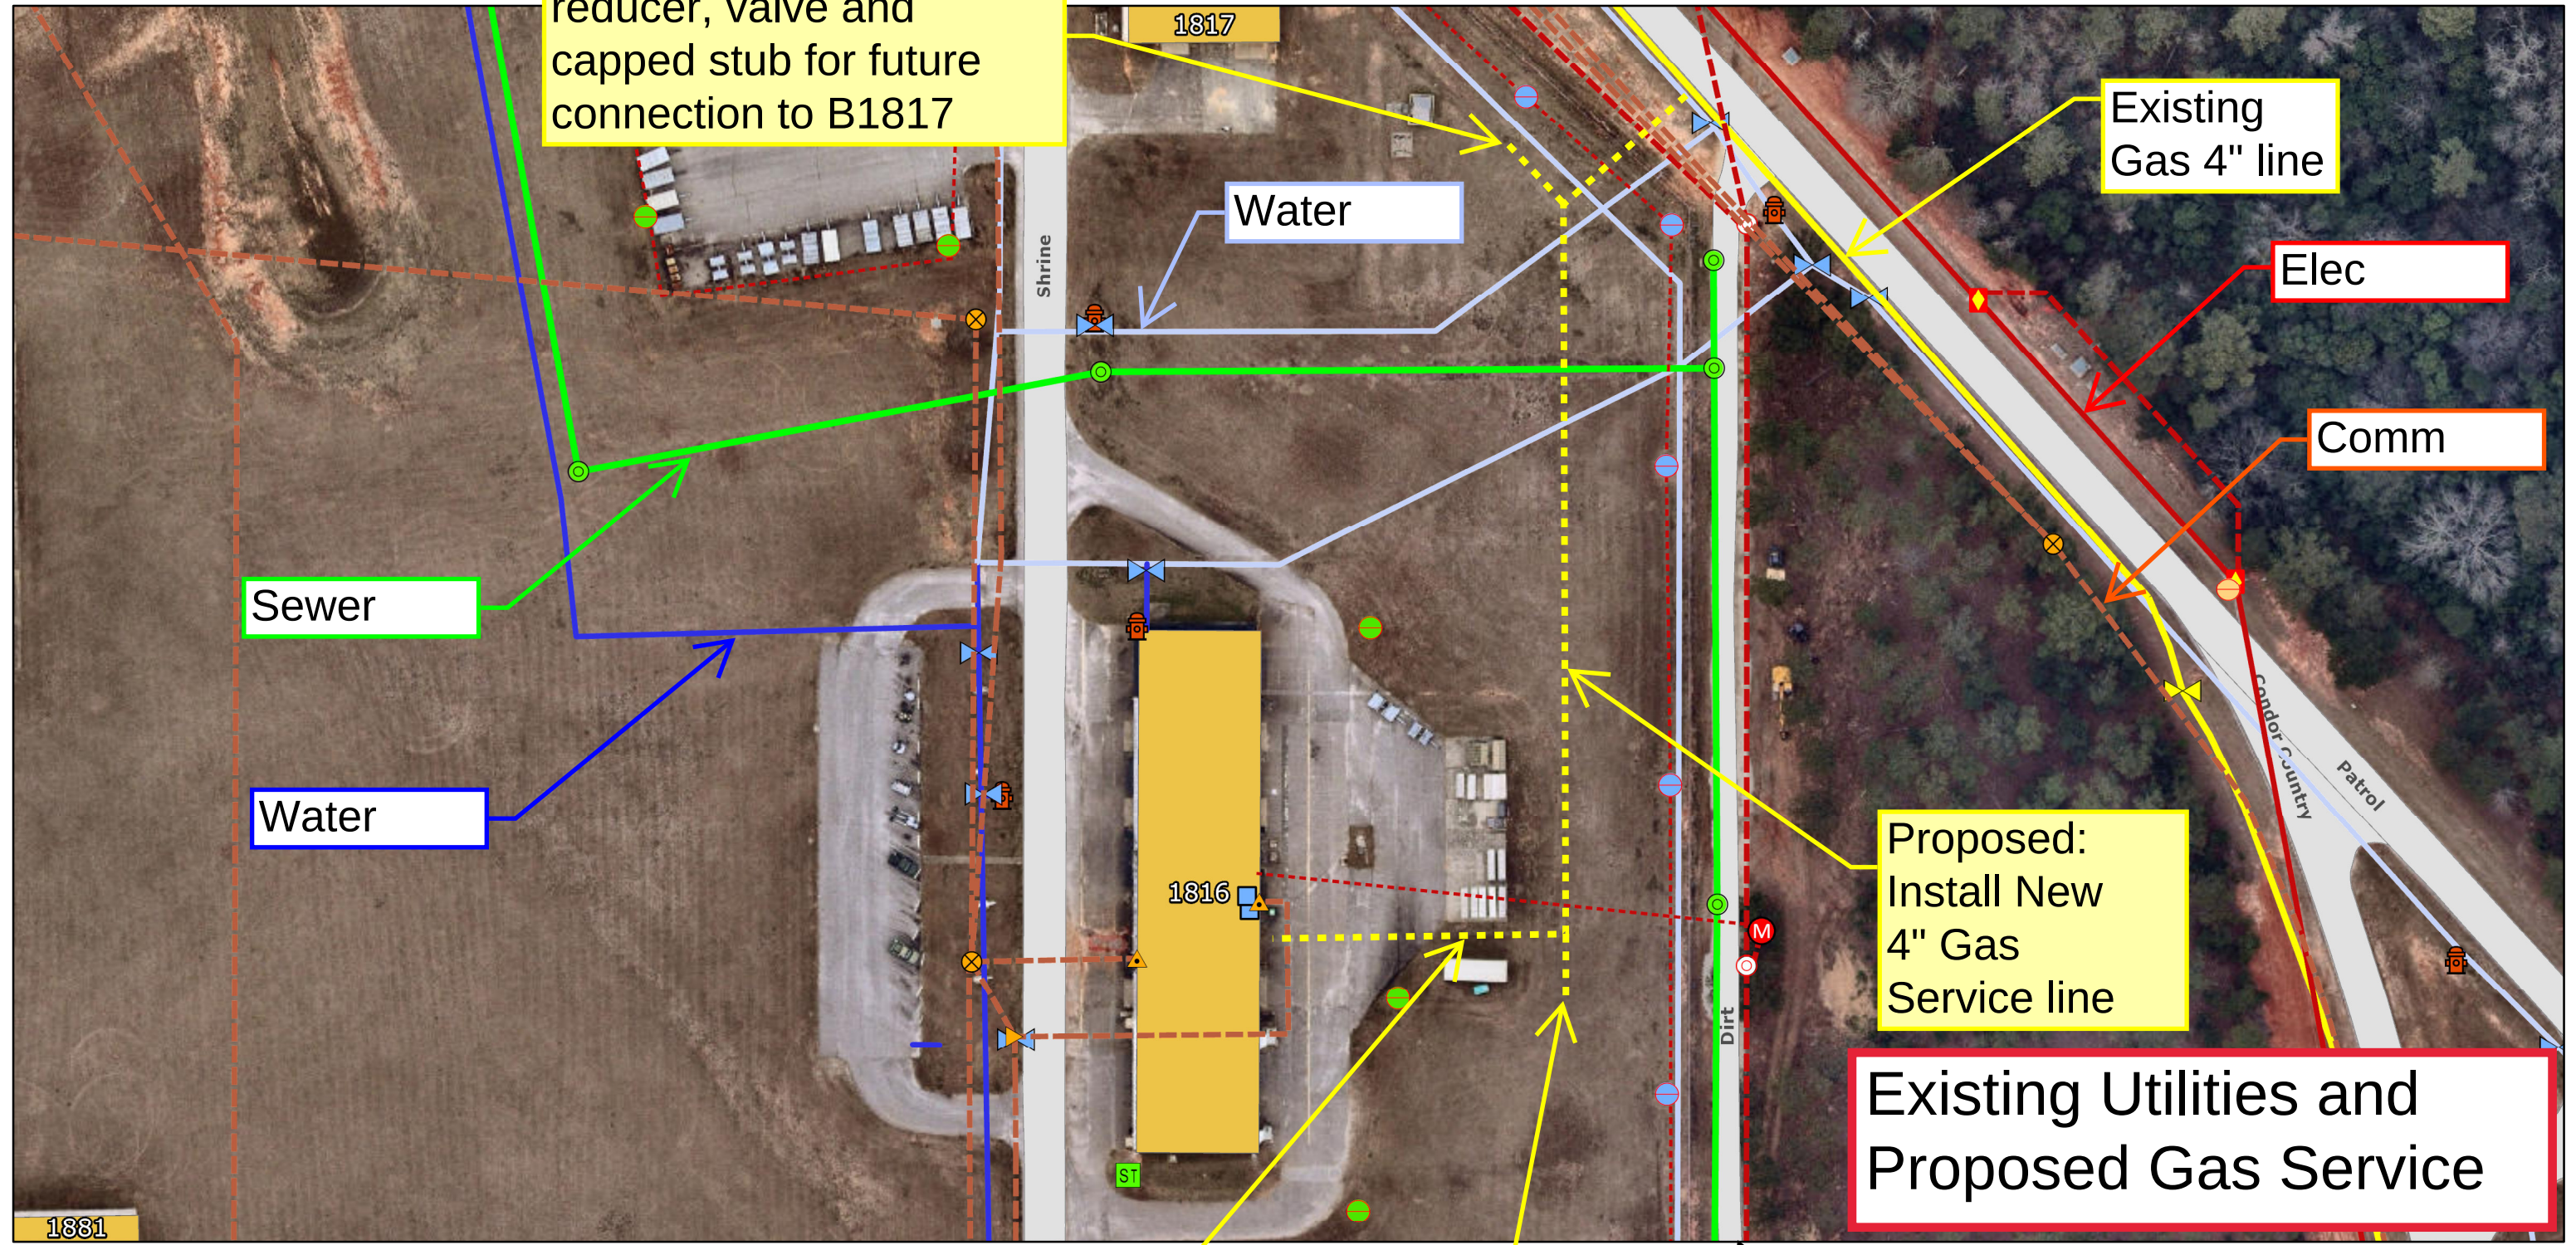

January 29, 2024


- ▲ Communication Antenna
- Communication Access Point
- ⌵ Communication Amplifier
- ⌵ Communication Attenuator
- ⌵ Communication Device
- ⌵ Communication Ground Point
- ⌵ Communication Terminal
- ⌵ Communication Terminator

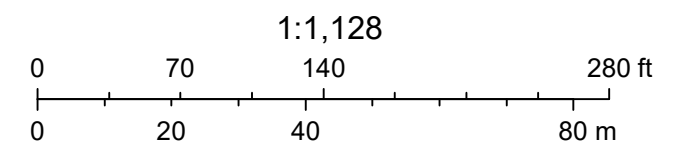

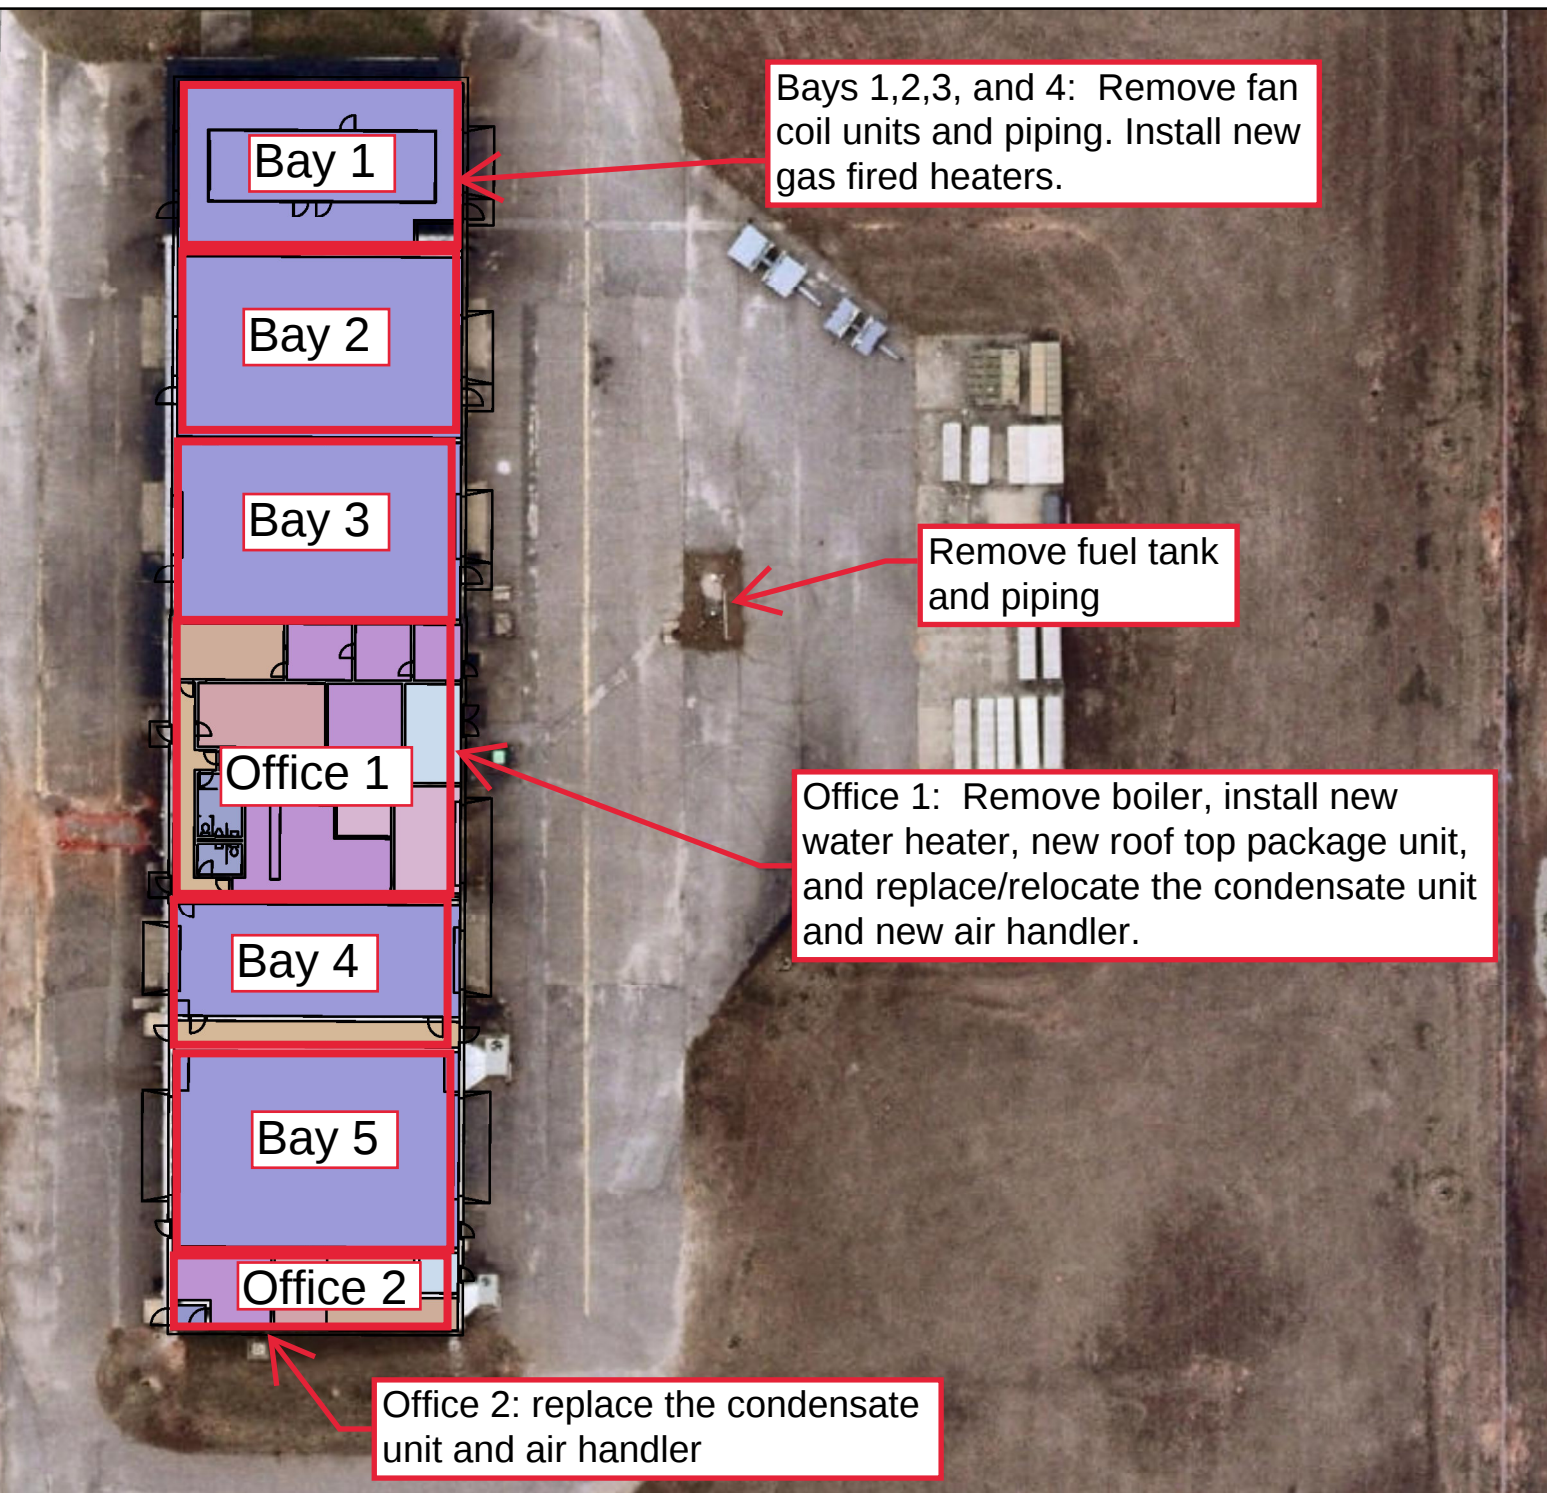

HVAC Plan

With Interior Bay Numbers

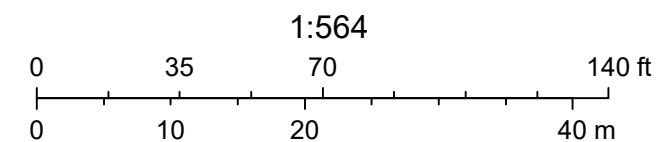

Not all requirements are shown on this plan. See Statement of Work for complete requirements.

Front of B1816



Rear of B1816

